


PLUMBING FIXTURE SCHEDULE

NO.	LOCATION	KEY	QTY	FIXTURE	MANUFACTURER / MODEL No.	FITTINGS	COMMENTS
119	MASTER BATH	LS1	2	LAVATORY SINK	VILLEROY & BOCH ARCHITECTURA UNDERMOUNT BASIN #6147.00 X WHITE WITH INTEGRATED OVERFLOW	- DORNBRACHT TARA THREE HOLE LAVATORY MIXER 20.713.892.00 - MODIFIED SPOUT TO REDUCE HEIGHT	FITTINGS TO MATCH EXISTING BUILDING STANDARD 1.85 GPM FLOW RATE
		WC1	2	WATER CLOSET	TOTO, AQUA WALL HUNG DUAL-FLUSH TOILET, CT418(FG)	- DORNBRACHT TARA TISSUE HOLDER WITHOUT COVER 83.500.892.00 - GERBERIT IN-WALL TANK FOR 2X4 INSTALL. 111.798.00.1 - VOLA DUAL FLUSH ACTUATOR A85 X 40, BRUSHED ST. STEEL	FITTINGS TO MATCH EXISTING BUILDING STANDARD
		SH1	2	SHOWER	CUSTOM SHOWER	- DORNBRACHT TARA THERMOSTAT TRIM 36.416.979.00 - DORNBRACHT THERMOSTAT ROUGH 35.517.970.90 - DORNBRACHT THERMOSTAT ADAPTOR 35.080.970.90 - (2) X DORNBRACHT TARA VOLUME CONTROL, 36.310.892.00 - SPEAKMAN SHOWERHEAD S-2251-PC - DORNBRACHT TARA HAND SHOWER SET WITH SLIDE BAR 26.403.892.00 - DORNBRACHT ELBOW 28.460.825.00 - DORNBRACHT ROUGH-IN ADAPTER 35.080.970.90 - STORMTECH-ARI SERIES OR INFINITY DRAIN AS65 SERIES SHOWER DRAIN	ALL FITTINGS TO MATCH EXISTING BUILDING STANDARD EXCEPT SHOWER HEADS 2.5 GPM MAX. FLOW AT HANDSHOWER 2.5 GPM MAX. FLOW AT SHOWERHEAD
		BT1	1	BATH TUB	WYNDHAM COLLECTION, SOHO 60" FREESTANDING SOAKING TUB MODEL WC-BT1002-60 X POLISHED CHROME FITTINGS	- DORNBRACHT TARA LOGIC SINGLE LEVER TUB MIXER FOR FREESTANDING INSTALLATION ON RISER WITH HAND SHOWER SET 25.943.892.00 - DORNBRACHT FLOOR MOUNTING ROUGH SET 35.944.970.90 - DORNBRACHT REMOTE PRESSURE VALVE 35.910.970.90	ALL FITTINGS TO MATCH EXISTING BUILDING STANDARD 2.5 GPM MAX. FLOW AT HANDSHOWER
<b>ACCESSORIES</b>							
119	MASTER BATH	RH1	2	ROBE HOOK	- DORNBRACHT, TARA, 83.251.220.00		TO MATCH EXISTING BUILDING STANDARD. LOCATIONS TO BE VERIFIED IN FIELD.
		TH1	2	TISSUE HOLDER	- DORNBRACHT, TARA, 83.500.892.00		TO MATCH EXISTING BUILDING STANDARD. PROVIDE MATCHING THREADED BUTTON FOR INSTALLATION ON GLASS PARTITION.
		TB1	2	TOWEL BAR	- CLR BMW24, CHROME, SINGLE SIDED TOWEL BARS		
		TB2	2	TOWEL BAR	- CUSTOM ALUMINUM BAR TO MATCH DRAWER PULLS		BY MILLWORKER
		TB3	4	TOWEL BAR	- CLR BMW24X24, CHROME, BACK-TO-BACK TOWEL BARS		
		HR1	6	PULL OUT ROD	- RAJACK, R234		- PROVIDE BOTTOM FLOOR MOUNTED AND TOP GLASS-TO-GLASS PIVOTS FOR SHOWER DOORS, CHROME. - PROVIDE MATCHING TRANSOM PIVOTS WITH EXTENDED ACTUATOR ROD. - PROVIDE BUTTON TYPE, GLASS-TO-GLASS AND GLASS-TO-WALL CONNECTORS, CHROME. - PROVIDE MOUNTING SHOE ABOVE CEILING FOR FIXED TRANSOM. - STANDARD SIZE 10" EXTENSION, 1" FLAT DISK TIP, US26 - POL. CHROME

**LEGEND**


SYCAMORE VENEER & EDGING
SUPER WHITE STONE
BIANCO NEVE STONE
CLEAR ANODIZED ETCHED ALUMINUM
CLEAR, LOW IRON GLASS
CLEAR, LOW IRON MIRROR
VENETIAN PLASTER

- GENERAL NOTES**
- CABINET PULLS ARE TO BE CUSTOM EDGE PULLS AS SHOWN ON DRAWINGS. ALUMINUM FINISH TO MATCH PROJECT STANDARD.
  - ALUM. GRILLS AT CABINET BASES TO BE 1/8" x 1/8" SPACE CONTINUOUS ANODIZED WITH CONCEALED FASTENING.

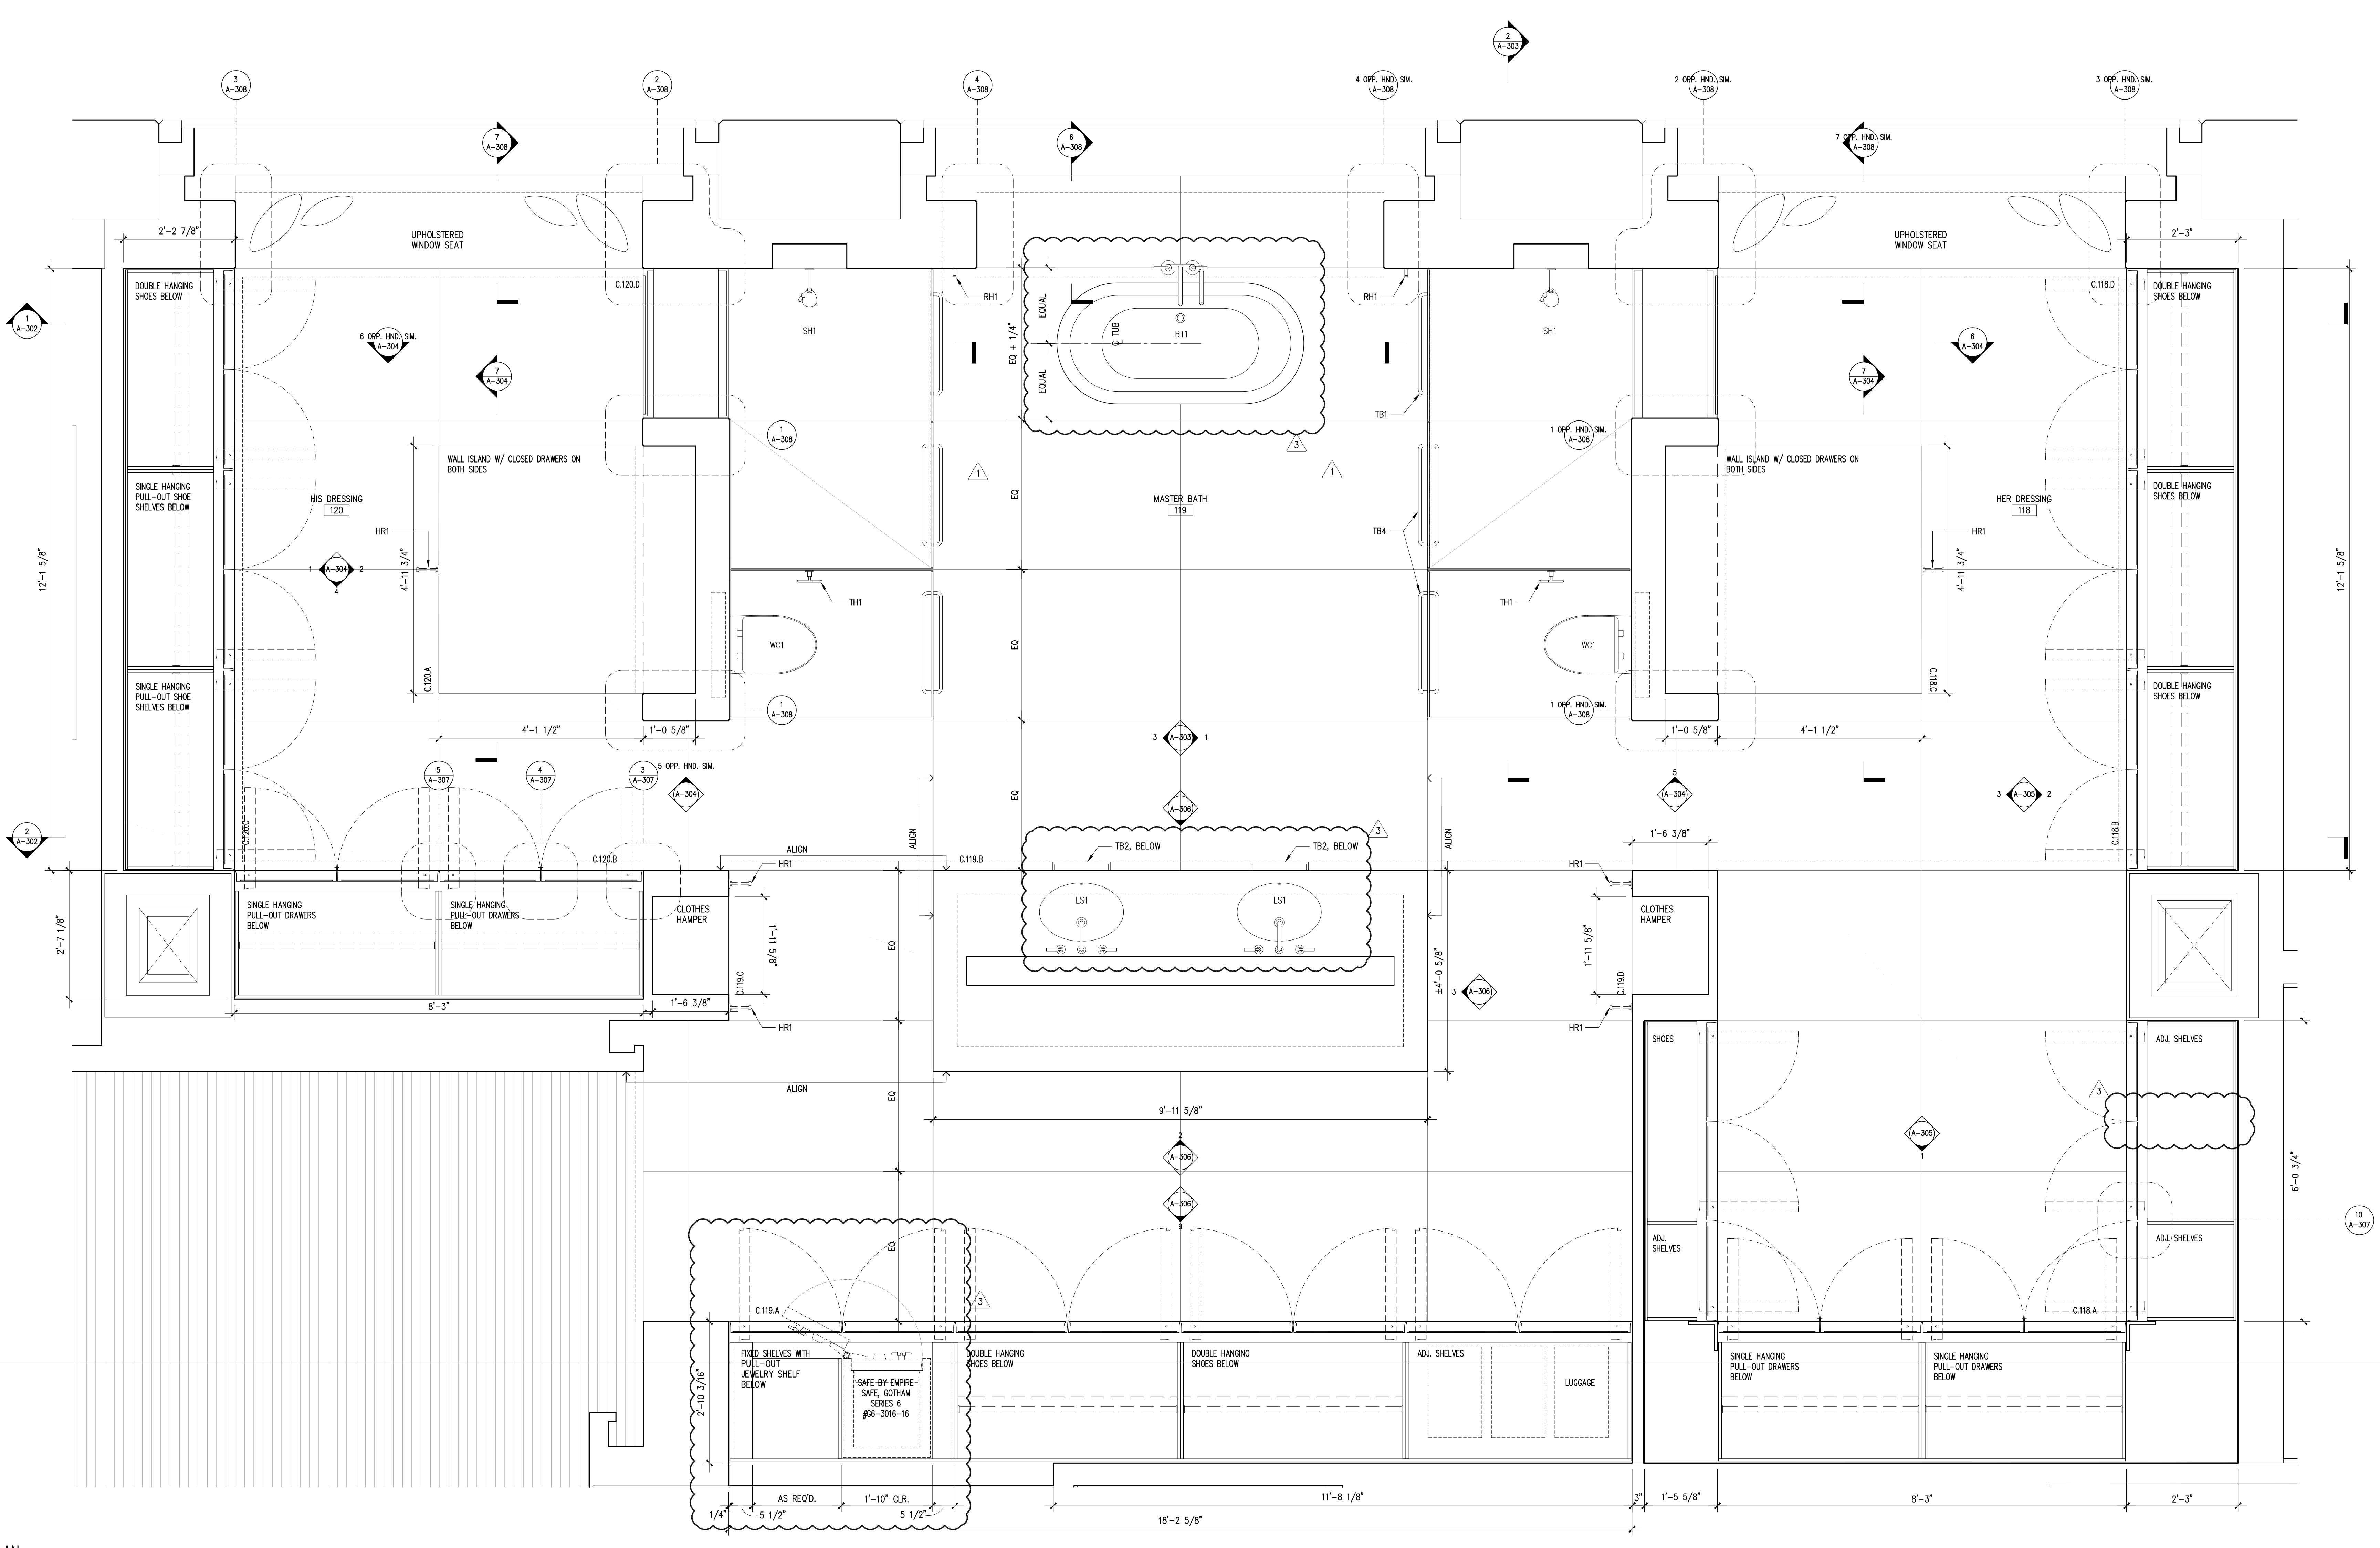

- 28 JAN 2017 REVISIONS AS BUBBLED  
 04 DEC 2017 REVISIONS AS BUBBLED  
 16 NOV 2017 REVISIONS AS BUBBLED  
 03 OCT 2017 ISSUE FOR COORDINATION  
 04 AUG 2017 FOR PRICING

No. Date Issues/Revisions  
**432 PARK APT. 78B**  
 432 PARK AVENUE, 61ST FLOOR NEW YORK, NY 10022

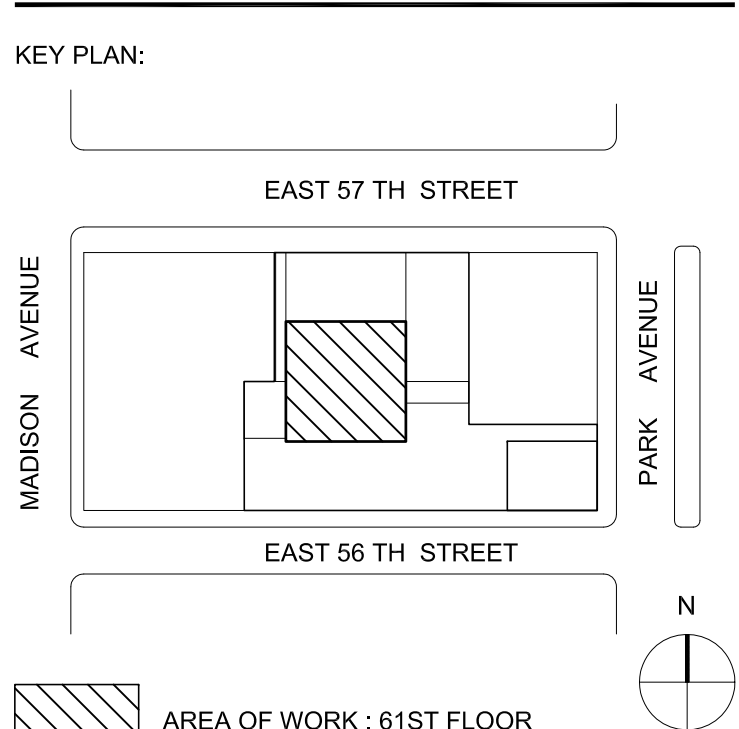

**KANG MODERN**  
 architects + interior designers  
 NEW YORK OFFICE  
 304 Madison Street, Suite 500  
 New York, NY 10017  
 T 212.462.2028  
 F 212.462.4788

WSP Flack & Kurtz  
 512 Seventh Avenue  
 New York, NY 10018  
 HDLC Architectural Lighting design  
 10 East 28th Street, 5th Floor  
 New York, NY 10016

M/E/P Engineers  
 Tel: (212) 535-9600  
 Lighting Designers  
 Tel: (212) 536-7800

**MASTER BATH AND MASTER DRESSING ROOM PLAN**  
 Scale: 3/4"=1'-0"  
 Date: 25 JAN 2017 **A-301**

1 DETAIL PLAN  
 3/4"=1'-0"

18249 SHEETS - SCALE IS FINAL WORKING SCALE  
 18248 SHEETS - SCALE IS 1/2"=1'-0" WORKING SCALE  
 18247 SHEETS - SCALE IS 1/2"=1'-0" WORKING SCALE  
 18246 SHEETS - SCALE IS 1/2"=1'-0" WORKING SCALE